

GENERAL NOTES

USE DIMENSIONS ONLY DO NOT SCALE DRAWINGS.

COMPLY WITH STATE, COUNTY AND LOCAL CODES, ORDINANCES AND REGULATIONS REGARDING CONSTRUCTION.

UTILITIES INCLUDING BUT NOT LIMITED TO WATER, GAS, ELECTRIC, CABLE, ETC SHALL BE CONNECTED IN ACCORDANCE WITH LOCAL CODES.

CONTRACTOR TO VERIFY ALL EXISTING CONDITIONS AND DIMENSIONS PRIOR TO COMMENCEMENT OF CONSTRUCTION AND TO VERIFY LOCATION OF UNDERGROUND UTILITIES TO DETERMINE CONNECTIONS.

THESE DRAWINGS ARE PREPARED IN COMPLIANCE WITH THE OBC RESIDENTIAL CODE AND MAY NOT REPRESENT COMPLETE PROFESSIONAL SERVICES. ARCHITECT IS NOT RESPONSIBLE FOR CONSTRUCTION SUPERVISION, JOB SAFETY, WORKMANSHIP AND ADHERENCE TO THE PLANS.

OWNER AND CONTRACTOR ASSUME RESPONSIBILITY FOR ALL JOB SITE SUPERVISION, SAFETY AND COMPLETION OF WORK.

THE CONTRACTOR IS RESPONSIBLE FOR COORDINATING THEIR WORK WITH THAT OF OTHERS AND SHALL BE HELD FOR ANY CHANGES OR ALTERATIONS RESULTING FROM THE FAILURE TO COORDINATE WORK INSTALLATION AND SEQUENCES.

VERIFY GRADES AND DETERMINE BUILDING REQUIREMENTS BASED UPON SURVEY AND ENGINEERING PROVIDED BY THE BUILDER.

THE CONTRACTOR DURING THE COURSE OF CONSTRUCTION KEEP THE SITE FREE OF DEBRIS AND WASTE MATERIALS CAUSED BY ITS OPERATIONS. THEY SHALL BE RESPONSIBLE FOR THE REMOVAL OF ALL WASTE MATERIAL. ALL CONSTRUCTION VEHICLES SHALL BE SUFFICIENTLY CLEAN UPON LEAVING THE SITE SO AS TO KEEP STREETS FREE OF DEBRIS.


THE CONTRACTOR SHALL INSTALL AND MAINTAIN ALL NECESSARY SAFETY BARRIERS, SEDIMENT CONTROLS, AND STORMWATER MANAGEMENT DEVICES.

DRAWING INDEX

- A1 COVER SHEET/NOTES/SITE PLAN
- A2 FLOOR PLAN
- A3 ELEVATION
- A4 ELEVATIONS
- A5 ELEVATION/WALL SECTION
- A6 SECTION/DETAIL
- E1 ELECTRICAL PLAN

VICINITY PLAN


NTS.

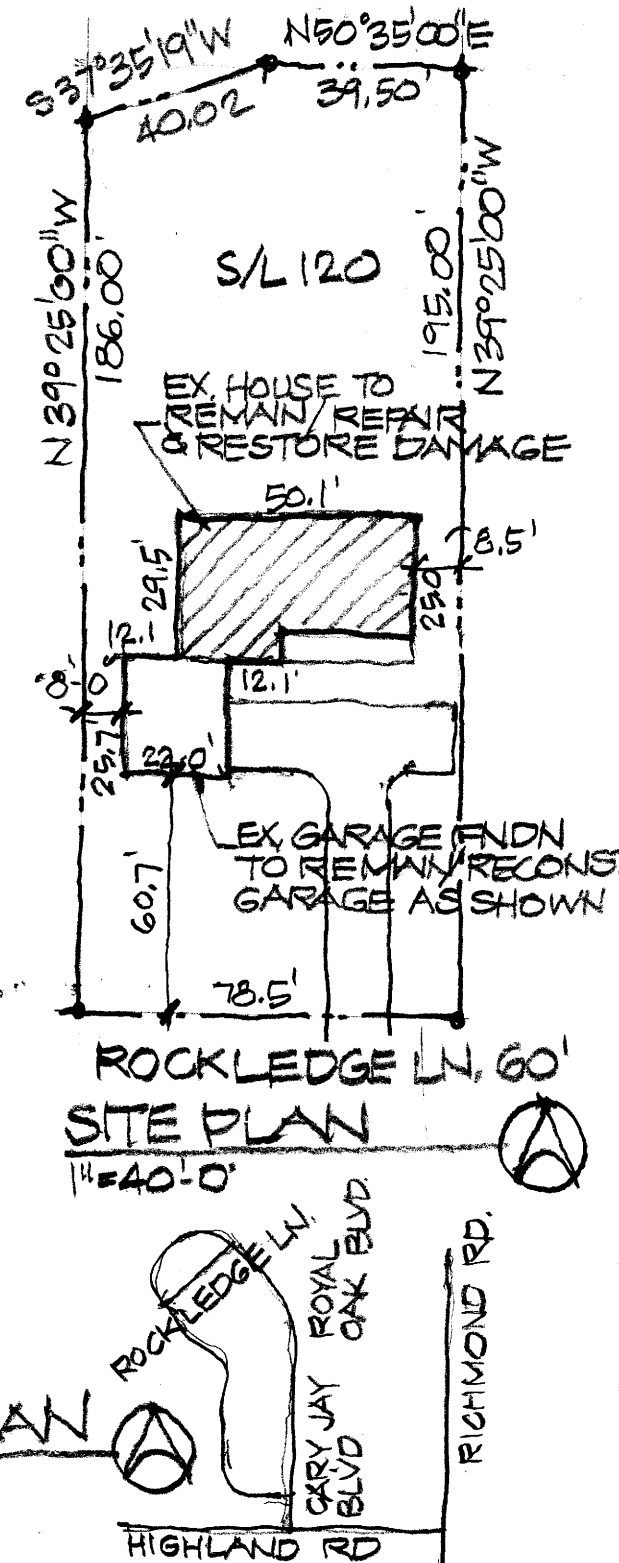

Design and construction documents are instruments of service given in confidence and remain the property of CIVITAD Services, LLC. The use of these documents for purposes other than the specific project named herein is strictly prohibited without expressed written consent of CIVITAD	
ISSUE	REVIEW
DATE	6/28/26


CARR RESIDENCE GARAGE RECONSTR.	24827 ROCKLEDGE RICHMOND HTS, OH
A	1

CIVITAD SERVICES, LLC
161 Orange Lake Drive
Orange Village, Ohio 44022
(216) 469-5370
www.civitaservices.com

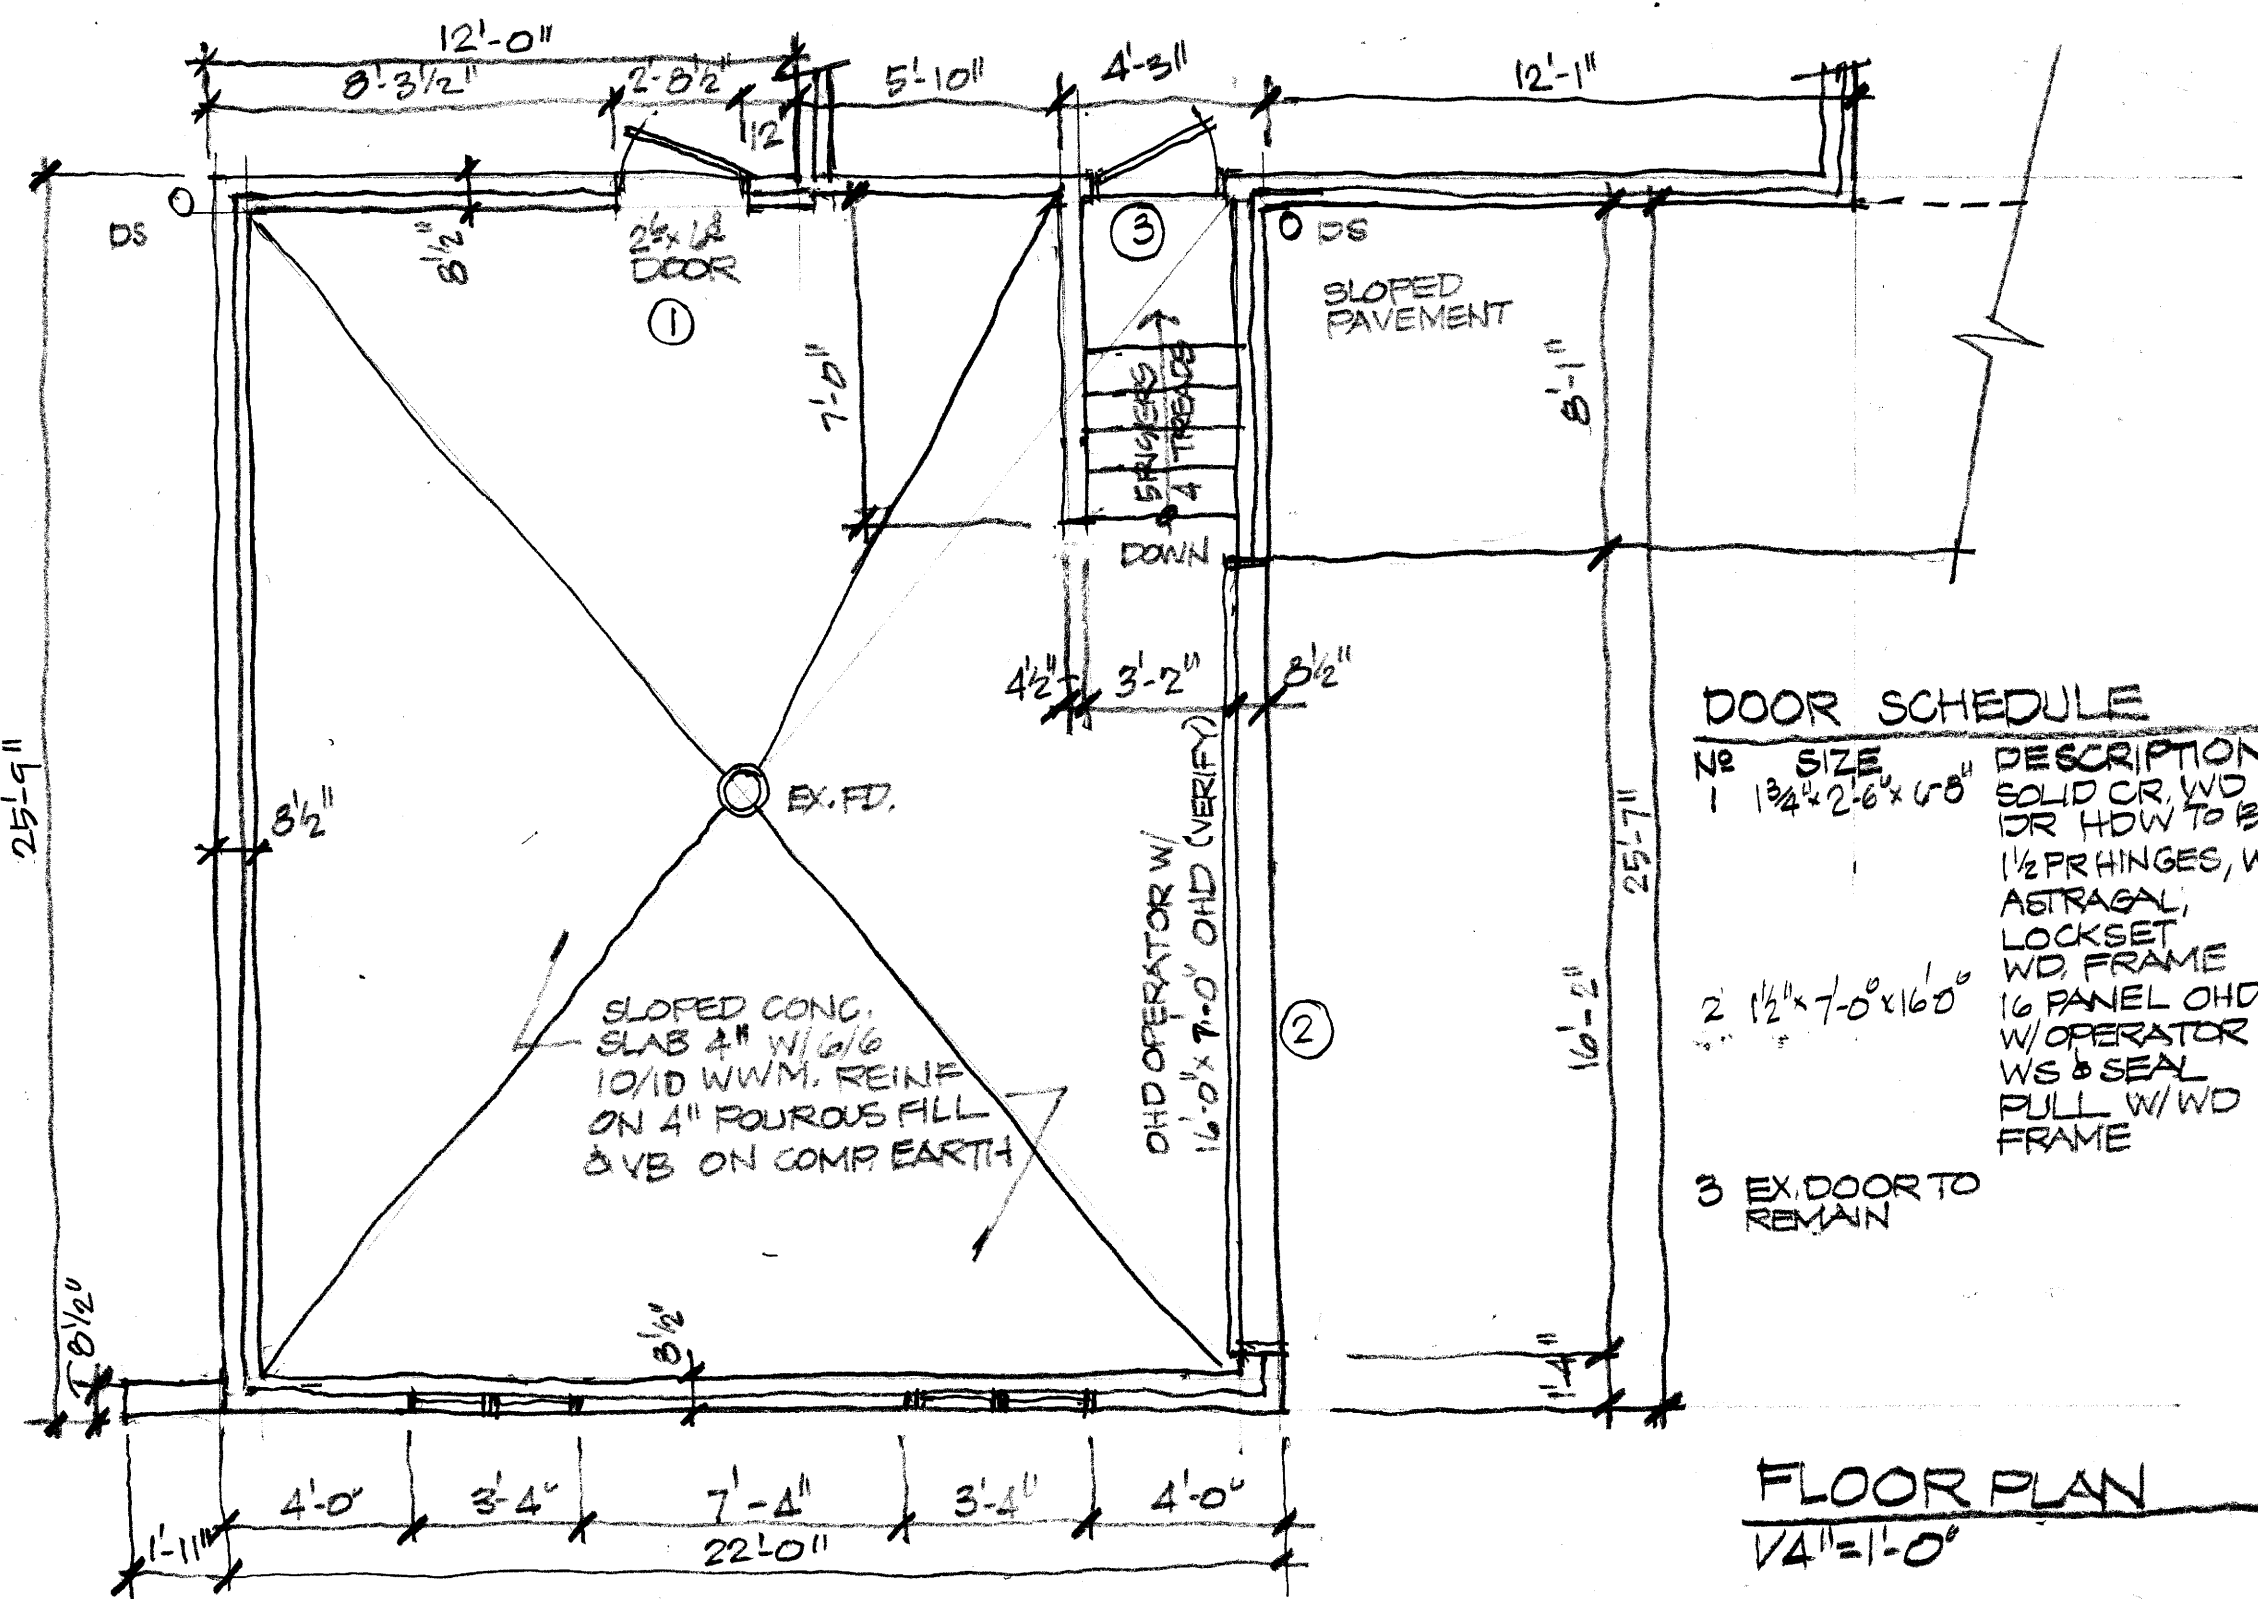

DOOR SCHEDULE		
No	SIZE	DESCRIPTION
1	13/4" x 2'-6" x 6'-8"	SOLID CR. WD 1DR HDW TO BE 1 1/2 PR HINGES, WS, ASTRAGAL, LOCKSET WD. FRAME
2	1 1/2" x 7'-0" x 16'-0"	16 PANEL OHD W/ OPERATOR WS & SEAL PULL W/ WD FRAME
3	EX. DOOR TO REMAIN	

FLOOR PLAN
1/4" = 1'-0"

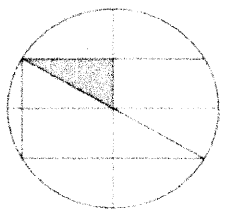

CIVITAD
SERVICES, LLC
161 Orange Lake Drive
Orange Village, Ohio
44022 (216) 469-5370
www.civitaservices.com


A

2

CARR RESIDENCE
GARAGE RECON
2807 ROCKLEDGE
RICHMOND HTS., OH.


DATE	ISSUE
6/23/26	REVIEW

Design and construction documents
instruments of service given in conflict
and remain the property of CIVITAD Ser
LLC. The use of these documents for
purposes other than the specific pr
named herein is strictly prohibited wi
expressed written consent of CH

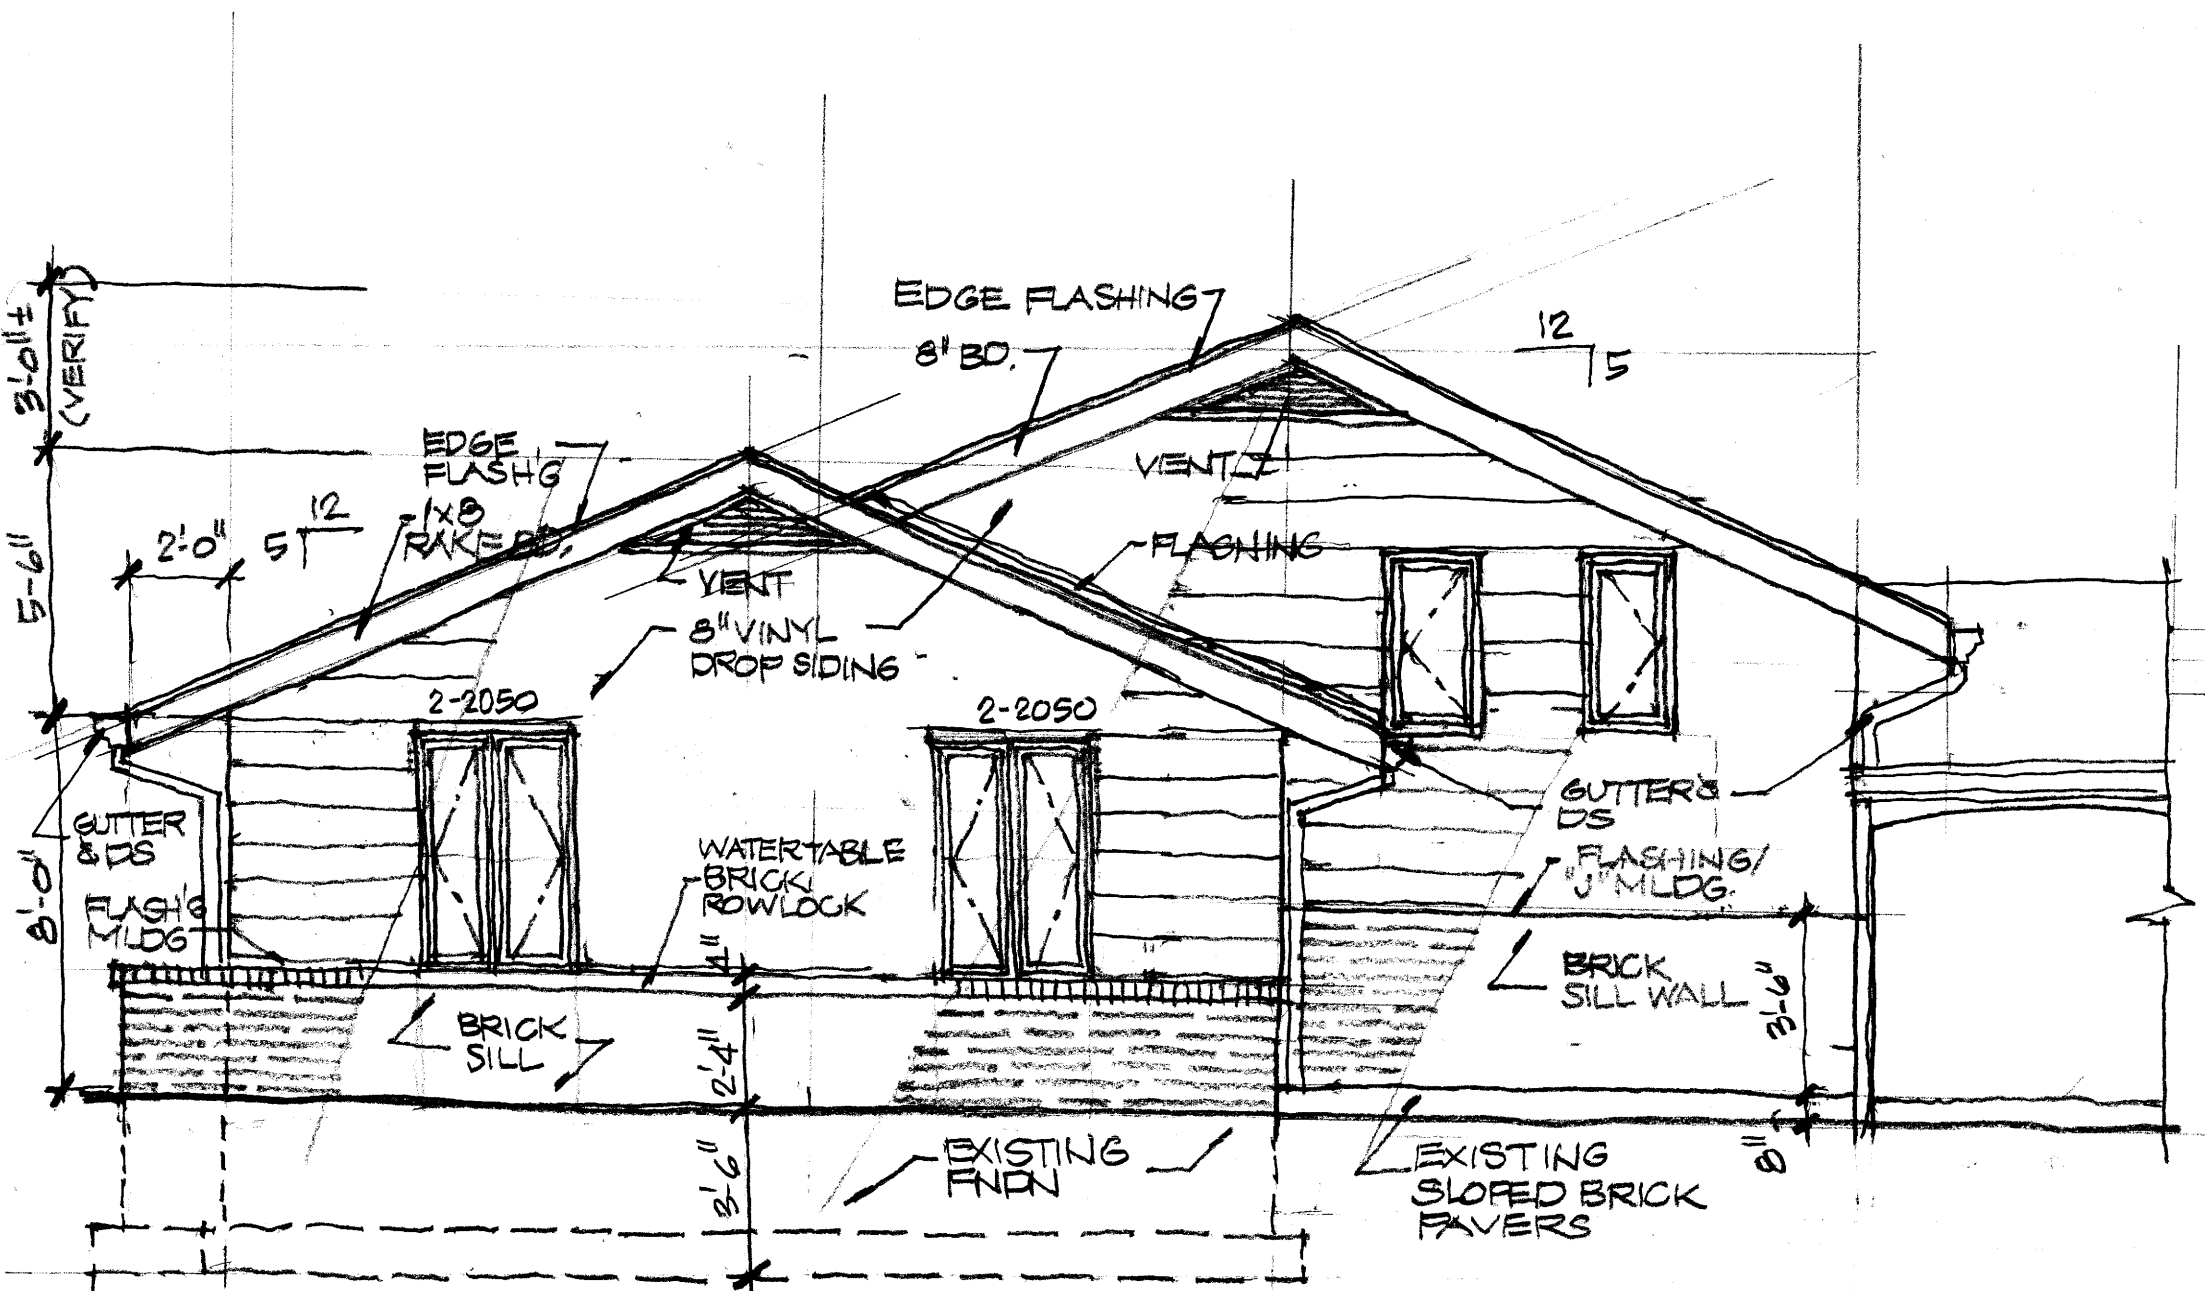

NOTE: VERIFY W/ OWNER
FOR SHUTTERS

SOUTH ELEVATION
1/4" = 1'-0"

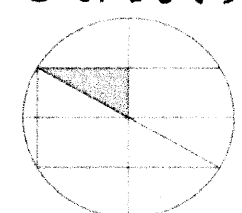


CIVITAD
SERVICES, LLC
161 Orange Lake Drive
Orange Village, Ohio
44022 (216) 469-5370
www.civitaservices.com

A


CARR RESIDENCE
GARAGE RECON
24827 ROCKLEDGE
RICHMOND HTS, OH

DATE	ISSUE
4/23/26	REVIEW


Design and construction documents
instruments of service given in confi
and remain the property of CIVITAD Ser
LLC. The use of these documents
purposes other than the specific pr
named herein is strictly prohibited wi
expressed written consent of CH

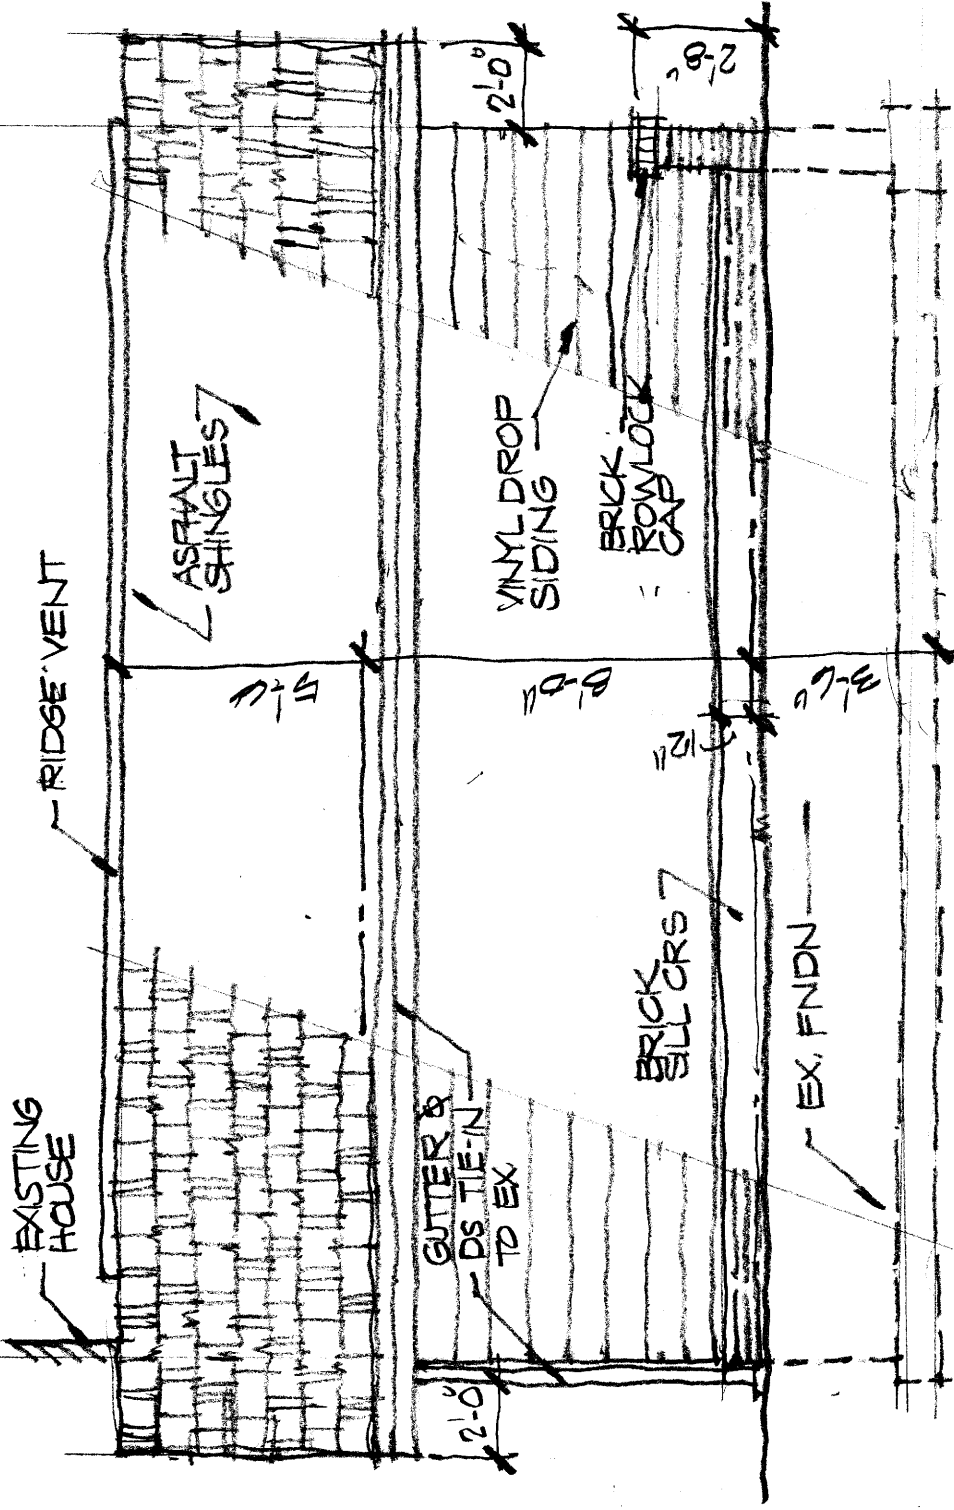

WEST ELEVATION
1/4" = 1'-0"

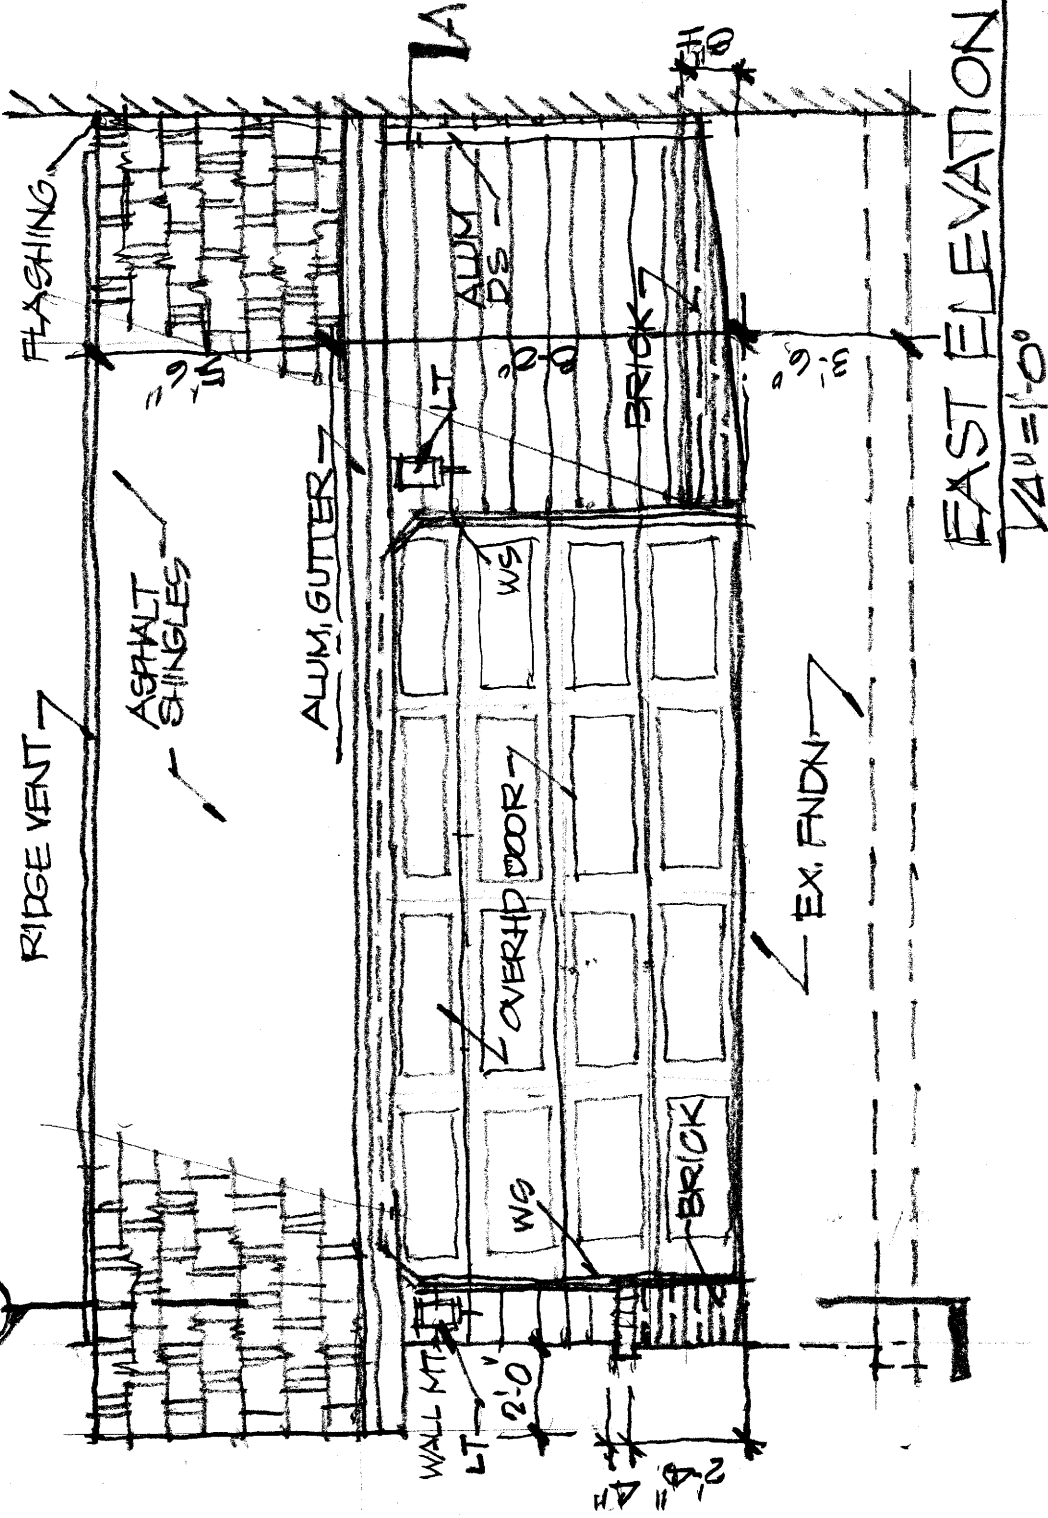

EAST ELEVATION
1/4" = 1'-0"

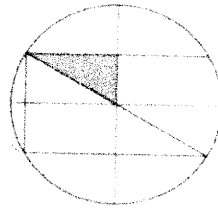

CIVITAD
SERVICES, LLC
161 Orange Lake Drive
Orange Village, Ohio
44022 (216) 469-5370
www.civitaservices.com

A


CARR RESIDENCE
GARAGE RECON

4


24827 ROCKLEDGE
RICHMOND HTS. OH

DATE	ISSUE
6/23/26	REVIEW

Design and construction documents
instruments of service given in confid
and remain the property of CIVITAD Ser
LLC. The use of these documents
purposes other than the specific pr
named herein is strictly prohibited wit
expressed written consent of CIV

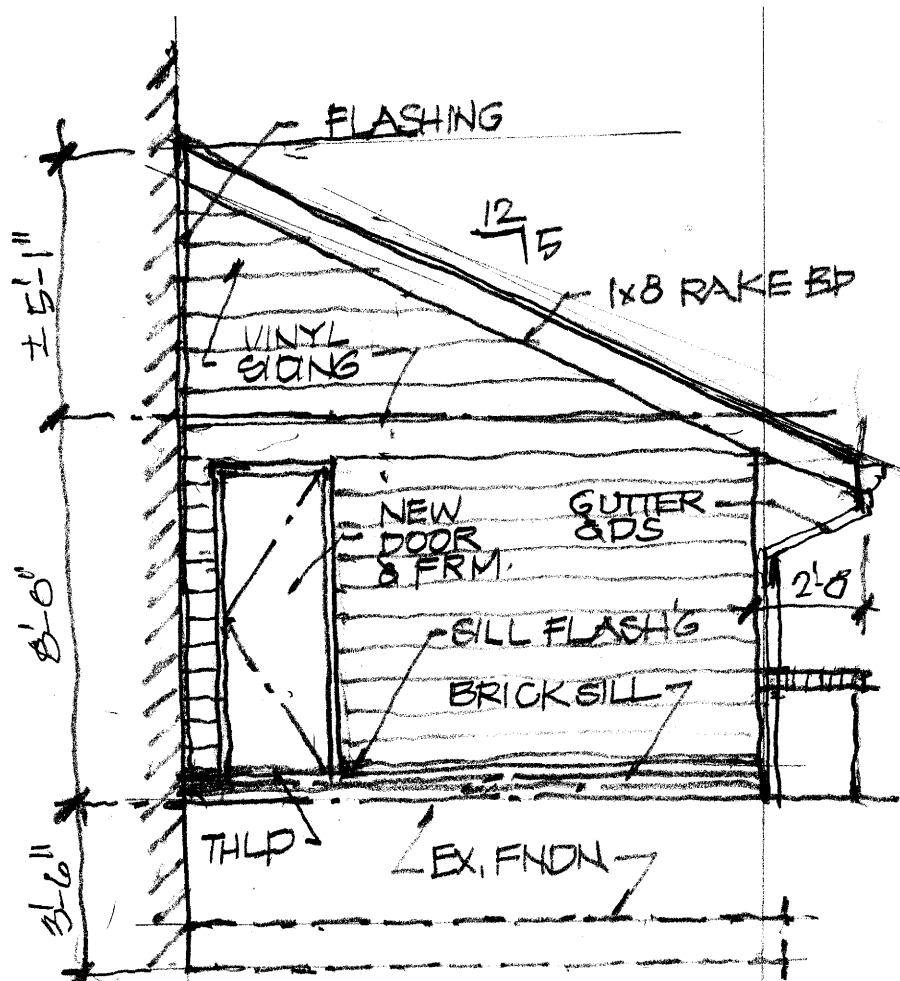

NORTH ELEVATION
1/4"=1'-0"

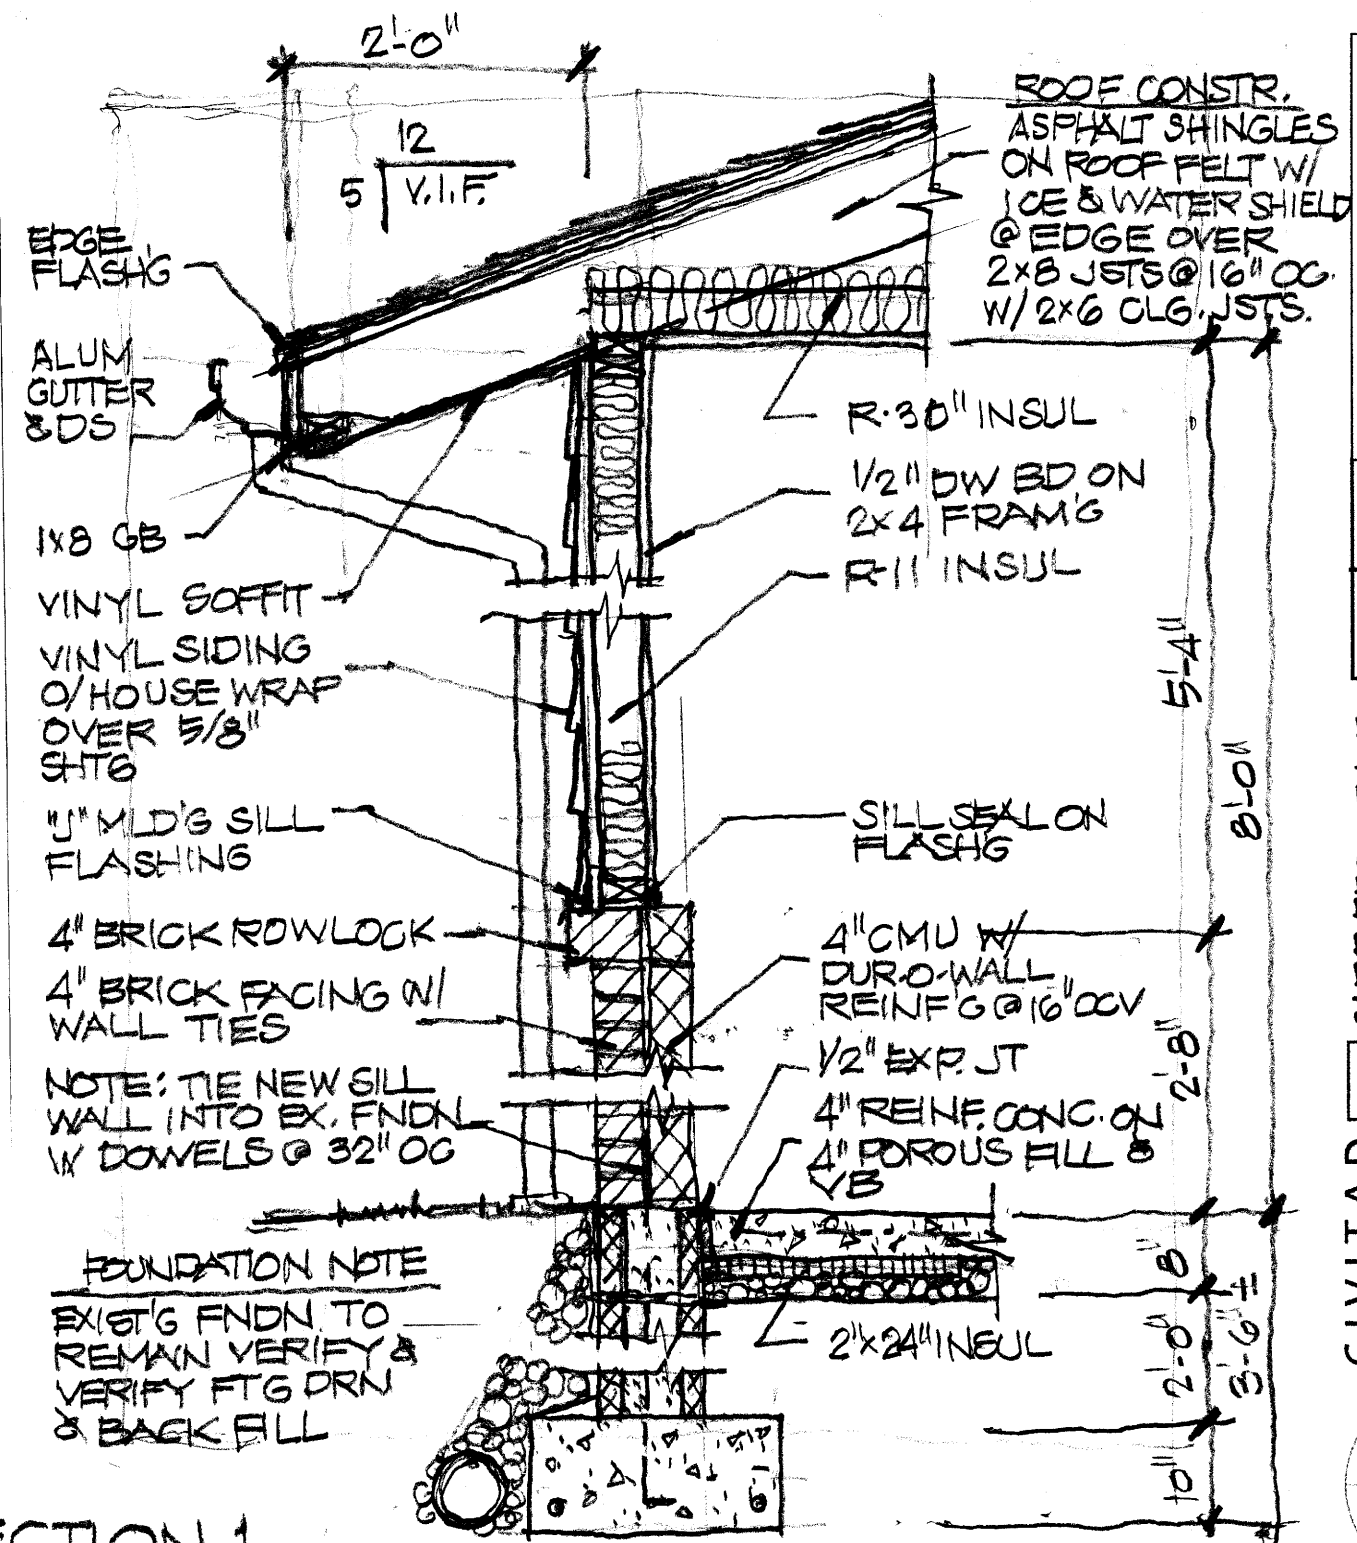


SECTION 1
3/4"=1'-0"


Design and construction documents are instruments of service given in confidence and remain the property of CIVITAD Services, LLC. The use of these documents for purposes other than the specific project named herein is strictly prohibited without expressed written consent of CIVITAD

DATE	ISSUE	REVIEW
6/23/26		

A	5
CARR RESIDENCE GARAGE RECONSTR.	
24827 ROCKLEDGE RICHMOND HTS., OH	

CIVITAD SERVICES, LLC
161 Orange Lake Drive
Orange Village, Ohio 44022
(216) 469-5370
www.civitaservices.com

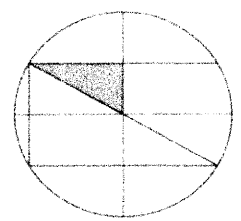

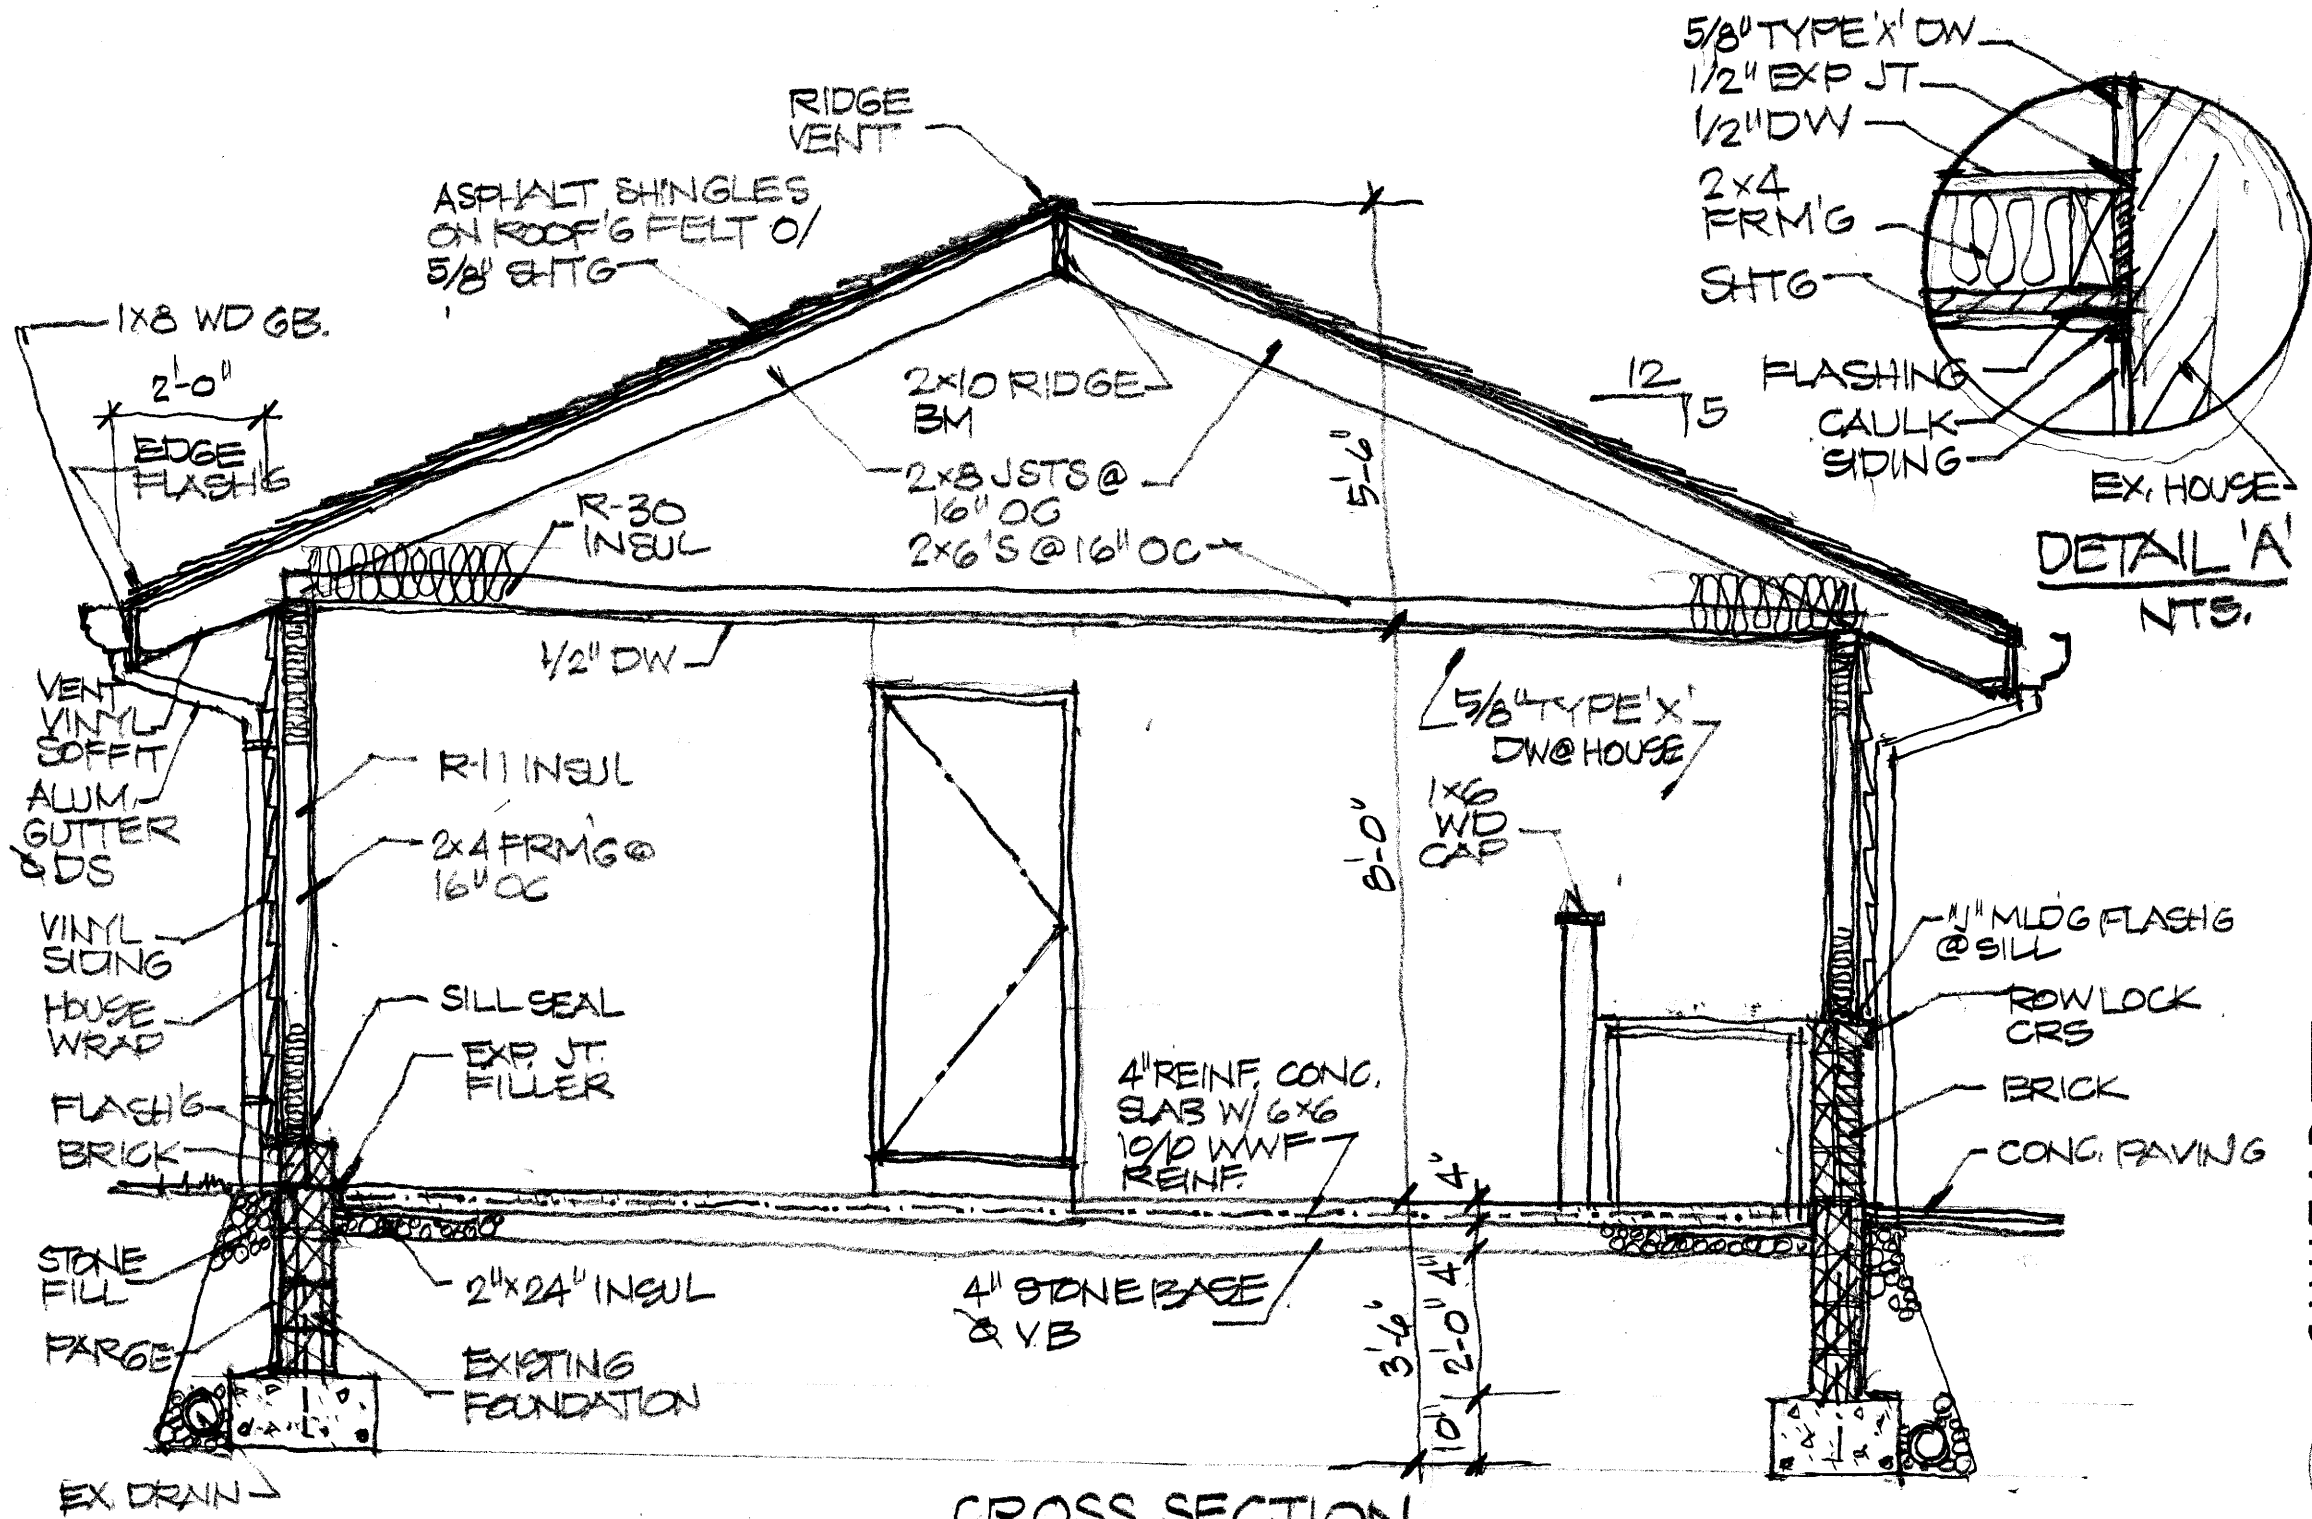

Design and construction documents are instruments of service given in confidence and remain the property of CIVITAD Services, LLC. The use of these documents for purposes other than the specific project named herein is strictly prohibited without expressed written consent of CIVITAD	
DATE	ISSUE
6/23/26	REVIEW

CIVITAD

SERVICES, LLC

161 Orange Lake Drive

Orange Village, Ohio

44022 (216) 469-5370

www.civitadservices.com

A


6


CARR RESIDENCE

GARAGE RECON.

24827 ROCKLEDGE

RICHMOND HTS., OH.

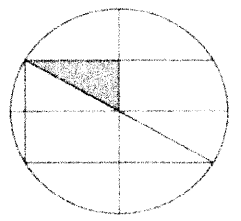

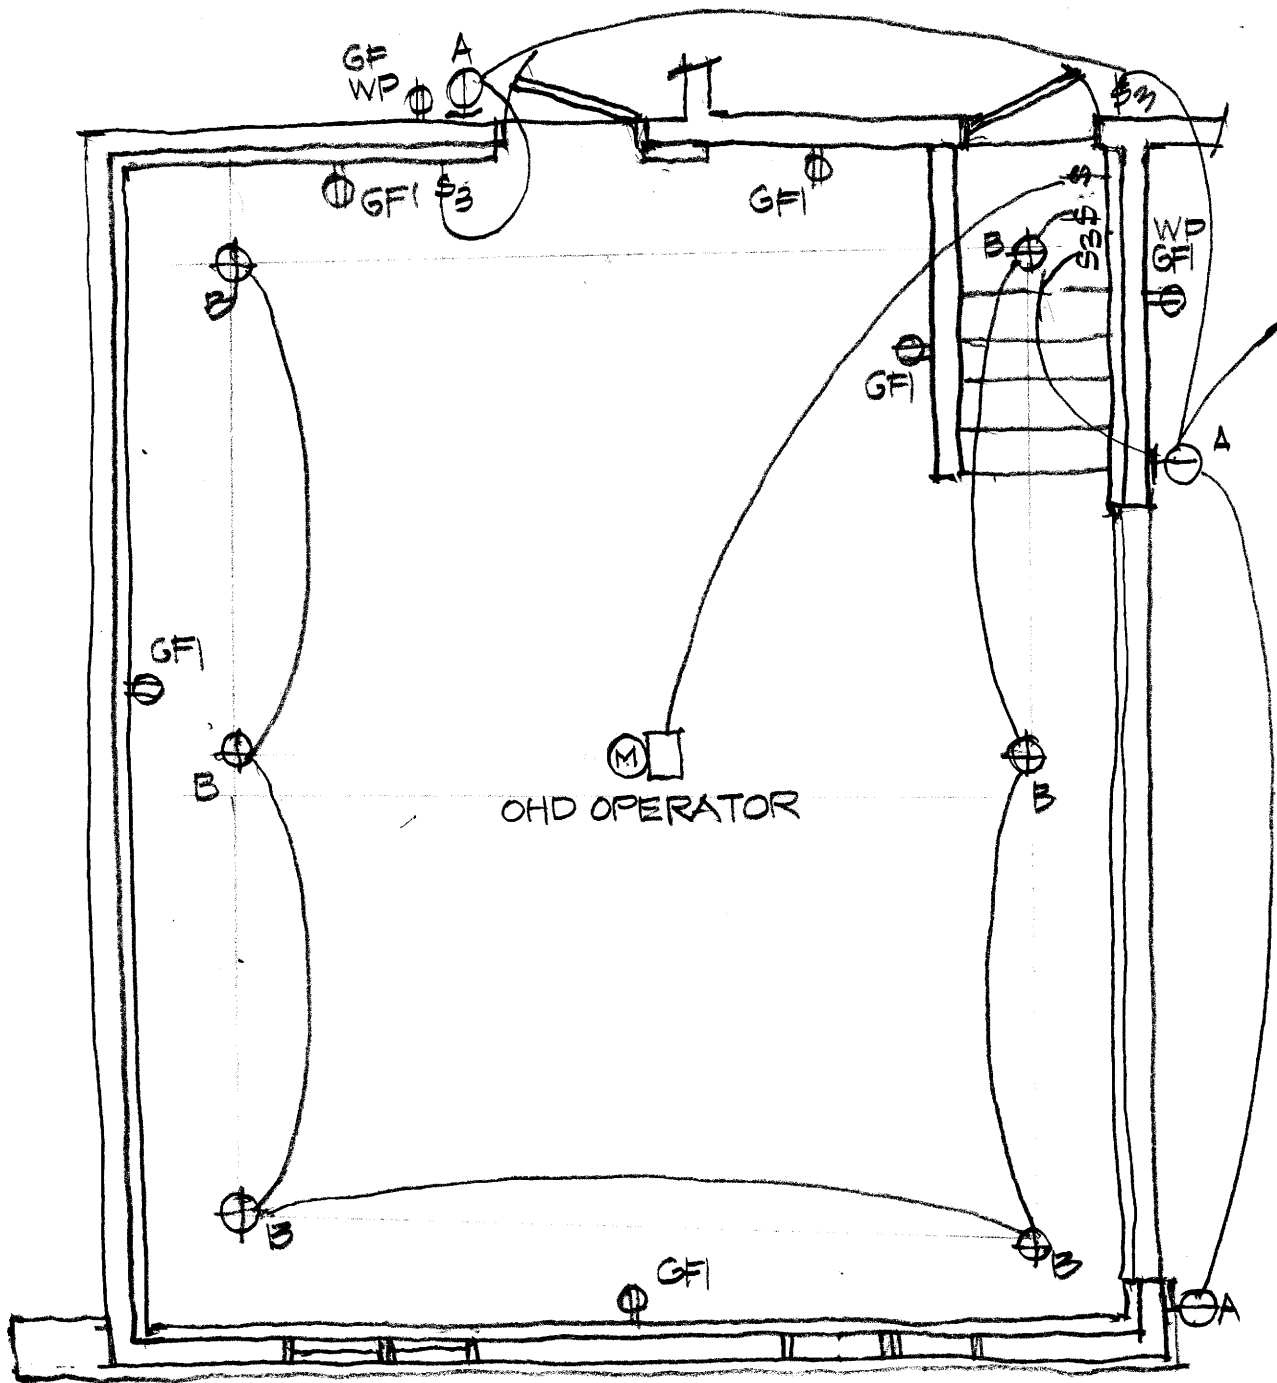

ELECTRIC FLOOR PLAN
 1/4" = 1' 0"

ELECTRICAL SCHEDULE

SYMBOL	DESCRIPTION
⊙A	WALL MTD. CARRIAGE LT LED
⊕B	CLG MTD GLOBE LED
Ⓜ	OVERHEAD DOOR OPERATOR
⊕GFI	DUPLEX GFI OUTLET
⊕GFI WP	DUPLEX GFI OUTLET WEATHER PROOF
\$	TOGGLE SWITCH 1P
\$3	TOGGLE SWITCH 3P
—	CIRCUIT

NOTE: TIE ELECTRIC INTO EX. PANEL

Design and construction documents are instruments of service given in confidence and remain the property of CIVITAD Services, LLC. The use of these documents for purposes other than the specific project named herein is strictly prohibited without expressed written consent of CIVITAD

DATE	ISSUE
6/23/26	PERMIT

CARR RESIDENCE
 GARAGE RECONSTR.

24827 ROCKLEDGE
 RICHMOND HTS., OH.

E	1
---	---

CIVITAD
 SERVICES, LLC
 161 Orange Lake Drive
 Orange Village, Ohio
 44022 (216) 469-5370
 www.civitaservices.com

